


The information contained in this drawing is the confidential property of Platinum Energy Services LTD. No part thereof shall be reproduced or communicated to a third party without written authorization from Platinum Energy Services LTD.

TIE-IN SCHEDULE			
MARK	SIZE / RATING	ELEVATION	DESCRIPTION
A	12" 600# RF	35 3/4" [908]	GAS INLET
B	8" 300# RF	102 1/4" [2597]	GAS OUTLET
C	3" 300# RF	12 5/8" [321]	WATER OUTLET/DRAIN
D	3" 300# RF	12 5/8" [321]	OIL OUTLET
E	4" 150# RF	108 1/4" [2750]	PSV OUTLET
F	1" 3000# NPT	26 1/4" [667]	INSTRUMENT AIR INLET
G	1" 3000# NPT	26 1/4" [667]	FUEL GAS SUPPLY
H	1" 3000# NPT	100" [2540]	FUEL GAS PSV OUTLET

NOTE: ALL ELEVATION DIMENSIONS FROM TOP OF CHECKER PLATE.

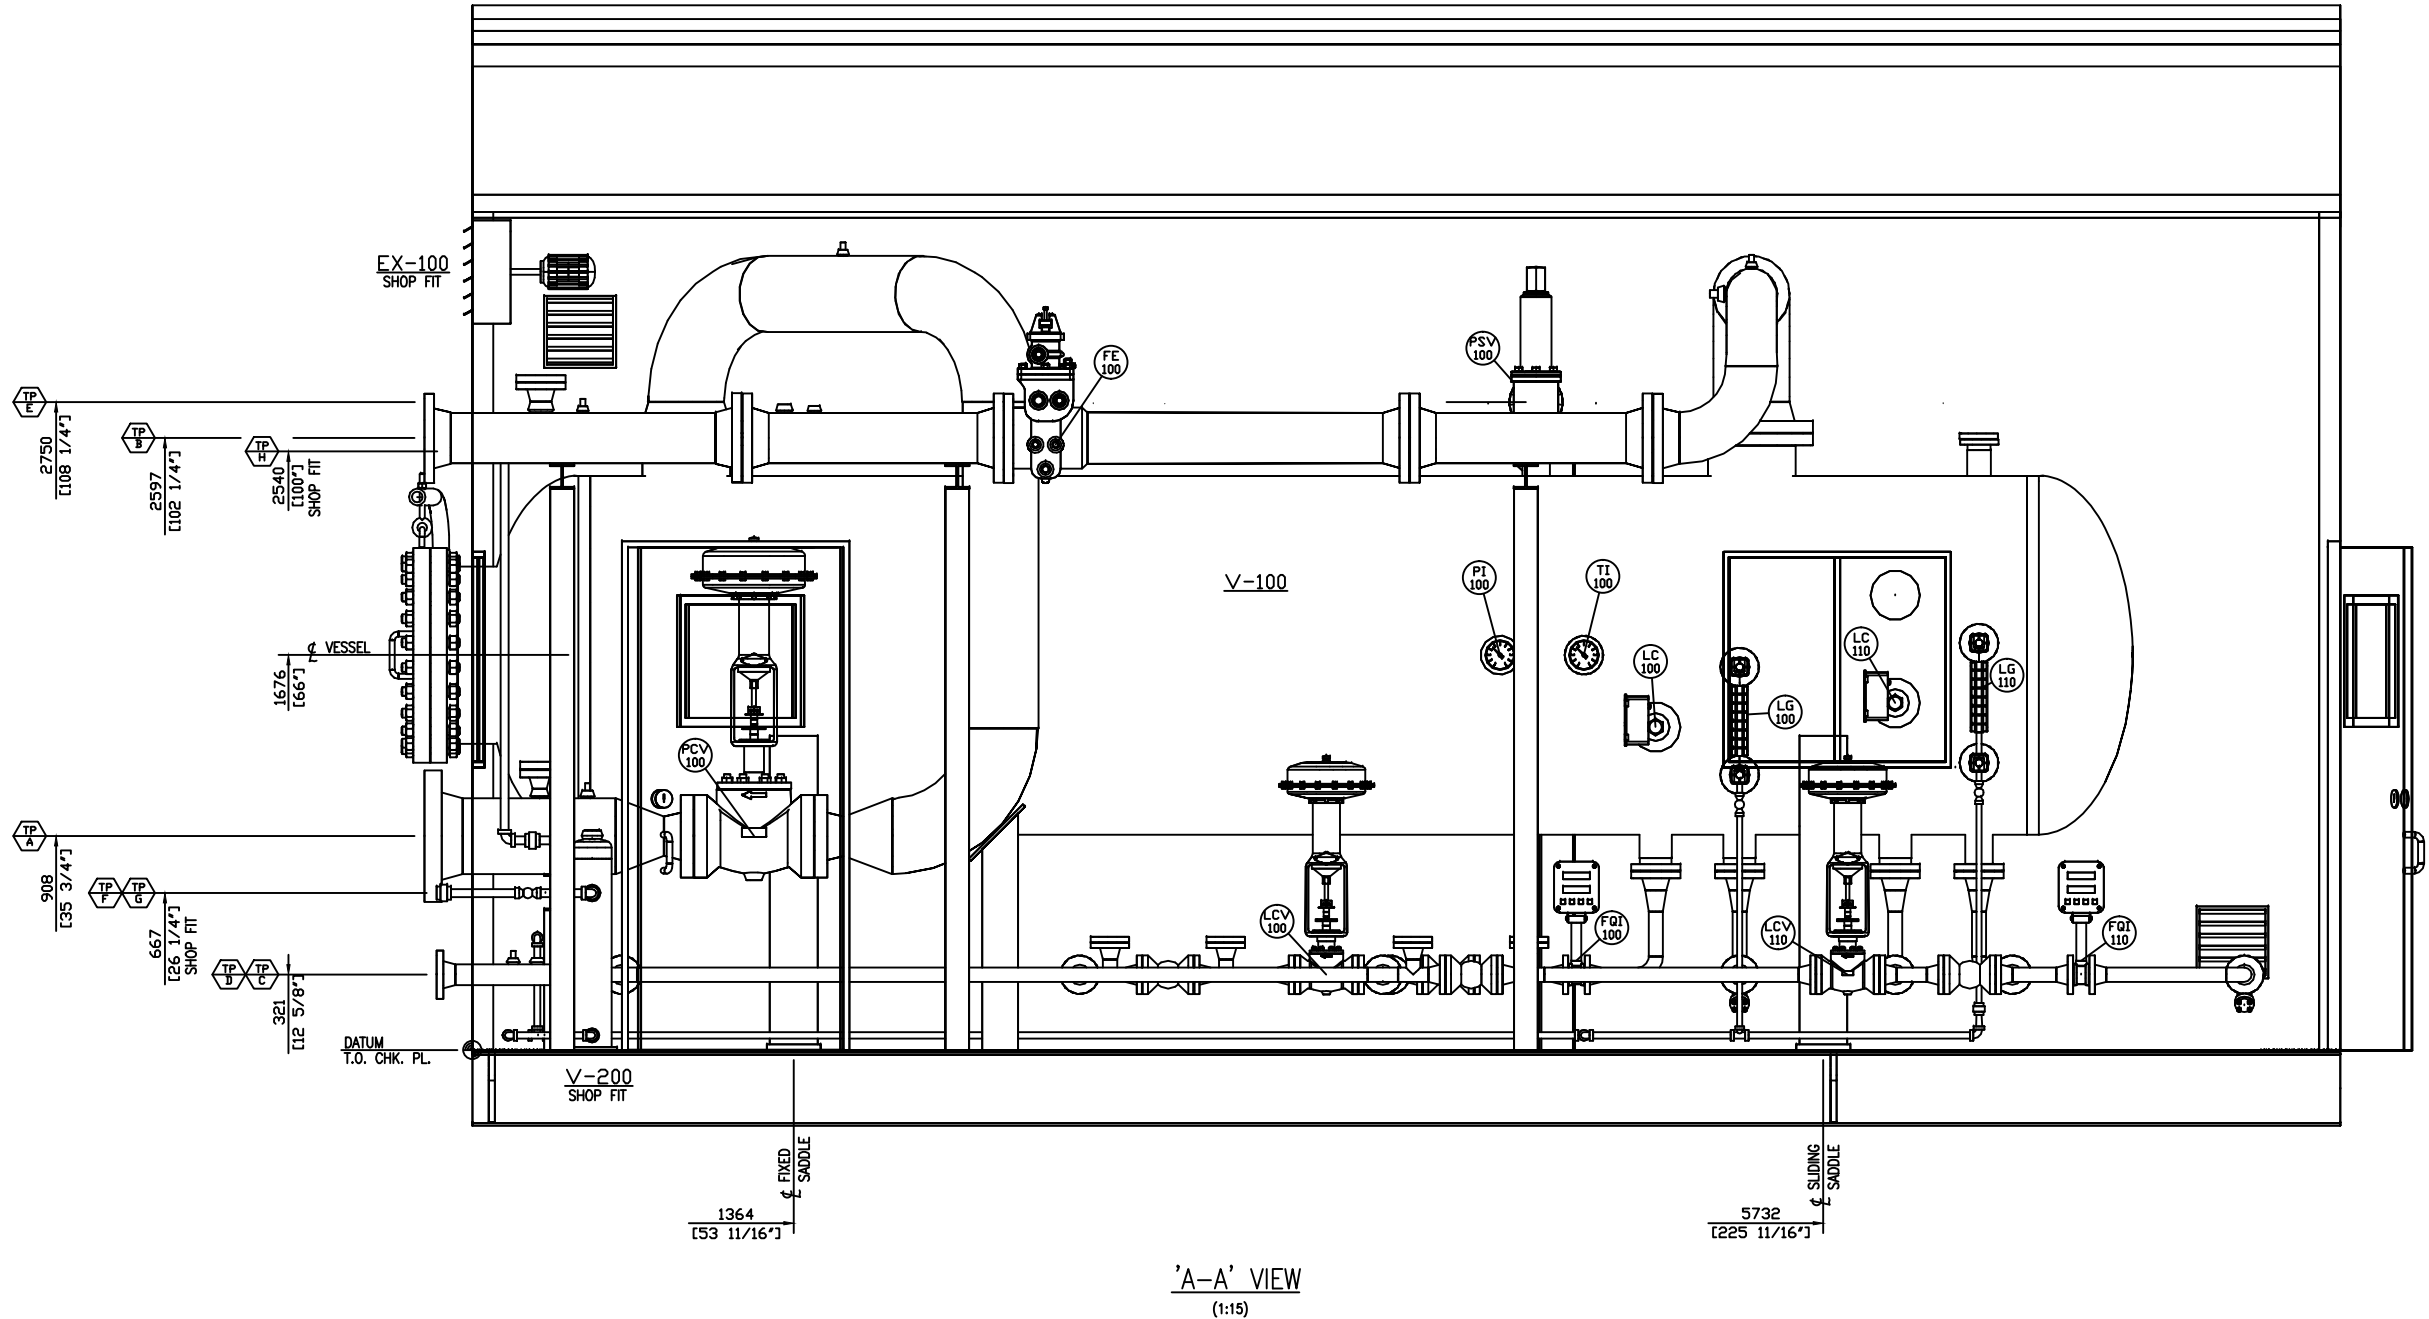

NOTES:

GA-05	GENERAL ARRANGEMENT - SE ISOMETRIC VIEW						
GA-04	GENERAL ARRANGEMENT - VIEW 'B-B' & 'C-C'						
GA-02	GENERAL ARRANGEMENT - PLAN VIEW						
GA-01	GENERAL ARRANGEMENT - SW ISOMETRIC VIEW						
SKD-01	STRUCTURAL STEEL						
PID-01	PIPING & INSTRUMENTATION DIAGRAM	0	ISSUED FOR CONSTRUCTION	CL	19-04-12	BX	DG
REFERENCE DRAWINGS		REV	DESCRIPTION	BY	DATE	CHK'D	APP'D

ENGINEER'S STAMP

DRAWN BY	CL	19-04-12
CHK'D BY	BX	19-04-12
APP'D BY	DG	19-04-12
CAD REF	30702-GA-03.DWG	SCALE AS SHOWN



CALGARY, ALBERTA

CLIENT		STOCK	
TITLE		60" OD x 20'-0" S/S 720 Psig HORIZONTAL SEPARATOR GENERAL ARRANGEMENT - 'A-A' VIEW	
JOB NO.	30702	DRAWING NO.	30702-GA-03
REV	0		